



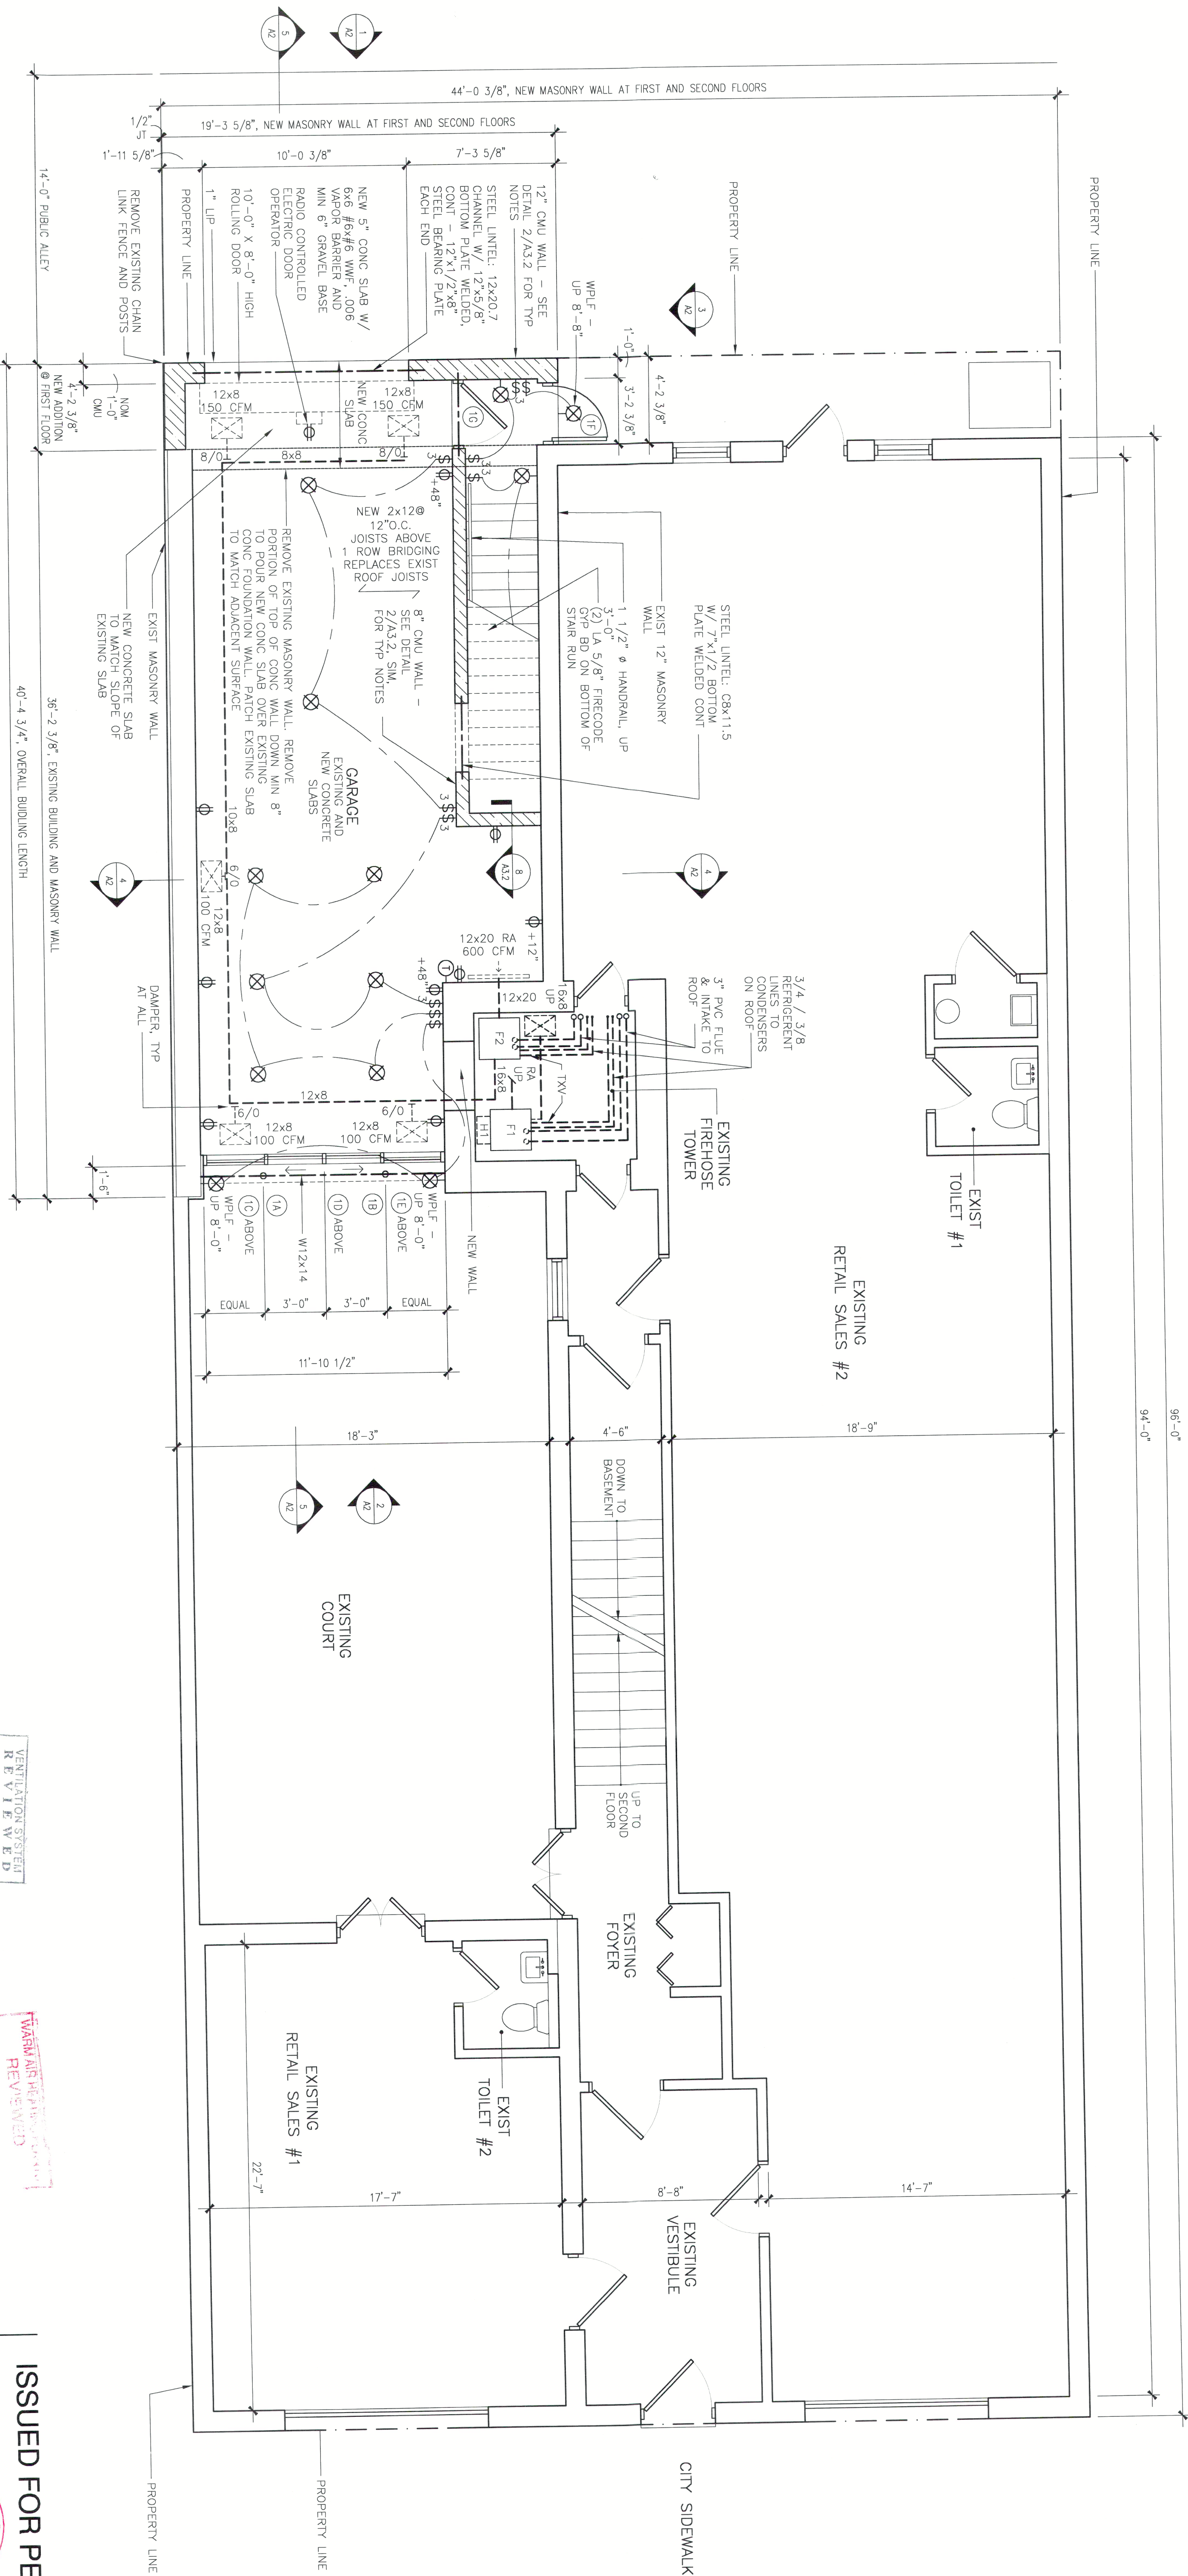


1 FIRST FLOOR PLAN
1/4"=1'-0"

NATURAL LIGHT/VENTILATION SCHEDULE					
NATURAL VENTILATION			NATURAL LIGHT		REMARKS
USE OF SPACE	AREA	CODE REQUIREMENT	% FLOOR AREA REQ'D	% FLOOR AREA PROVIDED	
GARAGE	528	NR	-	NR	

NOTE:
SEE SHEET A1.4 FOR CHICAGO VENTILATION NOTES AND
NEW EQUIPMENT SCHEDULE

* CORRECTIONS - page A1.2 (c)

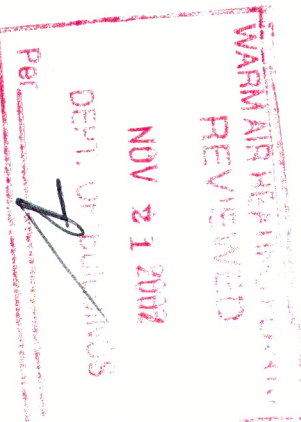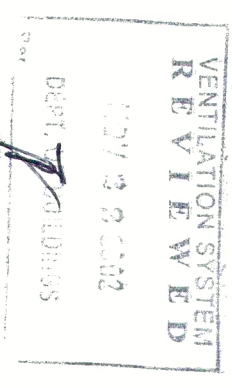

3-27-03

HEATING SCHEDULE (NEW ADDITION)				
USE OF SPACE/ ROOM NAME	BASIS OF HEAT LOSS CALCULATIONS	DESIGN HEAT LOSS (BTUH HEAT LOSS)	ORDINANCE REQUIREMENTS (SUPPLY CFM AT 175 F)	ACTUAL HEAT PROVIDED (SUPPLY CFM AT 175 F)
GARAGE	ASHRAE	32,420	NA	600
	TOTALS	32,420		600
SITTING	ASHRAE	30,085	55	500
LOFT	ASHRAE	12,150	25	300
	TOTALS	42,235		800

ISSUED FOR PERMIT



LEONARD WISNIEWSKI, ARCHITECT
2834 N. STATE ROUTE ONE
MARTINTON TOWNSHIP, ILLINOIS 60951
TEL: 815.428.7556

FIRST FLOOR PLAN, FIRST
FLOOR LIGHT AND VENTILATION
SCHEDULE & HEATING SCHEDULE
Scale: 1/4" = 1'-0"
Date: 10.15.02
File: 0205.A1-2

